


ELECTRICAL SYMBOLS


□	WALL MOUNTED FLUORESCENT LIGHT FIXTURE	●	RECESSED WALL WASHER	\$	SWITCH, SINGLE POLE	□	EMERGENCY HORN
□	SURFACE MOUNTED FLUORESCENT LIGHT FIXTURE	○	PENDANT LIGHT - SEE PLANS FOR SIZE	\$0	SWITCH, DIMMER	□	EMERGENCY HORN WITH STROBE FOR HEARING IMPAIRED
□	RECESSED FLUORESCENT LIGHT FIXTURE	⚡	EMERGENCY LIGHT	\$2	SWITCH, TWO WAY	□	HEARING IMPAIRED
□	RECESSED FLUORESCENT LIGHT FIXTURE	⊖	THERMOSTAT	\$8	SWITCH, THREE WAY	□	HEARING IMPAIRED
□	SURFACE MOUNT LIGHT FIXTURE	⊕	JUNCTION BOX	▶	TELEPHONE/DATA OUTLET	⊗	EXHAUST FAN
□	FLUORESCENT WALL MOUNT	⊖	RECEPTACLE, DUPLEX	▶	DATA OUTLET	⊗	DIRECTIONAL EXIT LIGHT
□	FLUORESCENT RECESSED	⊖	RECEPTACLE, DBL. DUPLEX	▶	TELEPHONE JACK	⊗	SMOKE DETECTOR
□	WALL SCONCE	⊖	FLOOR RECEPTACLE, DUPLEX	▶	TELEVISION JACK		

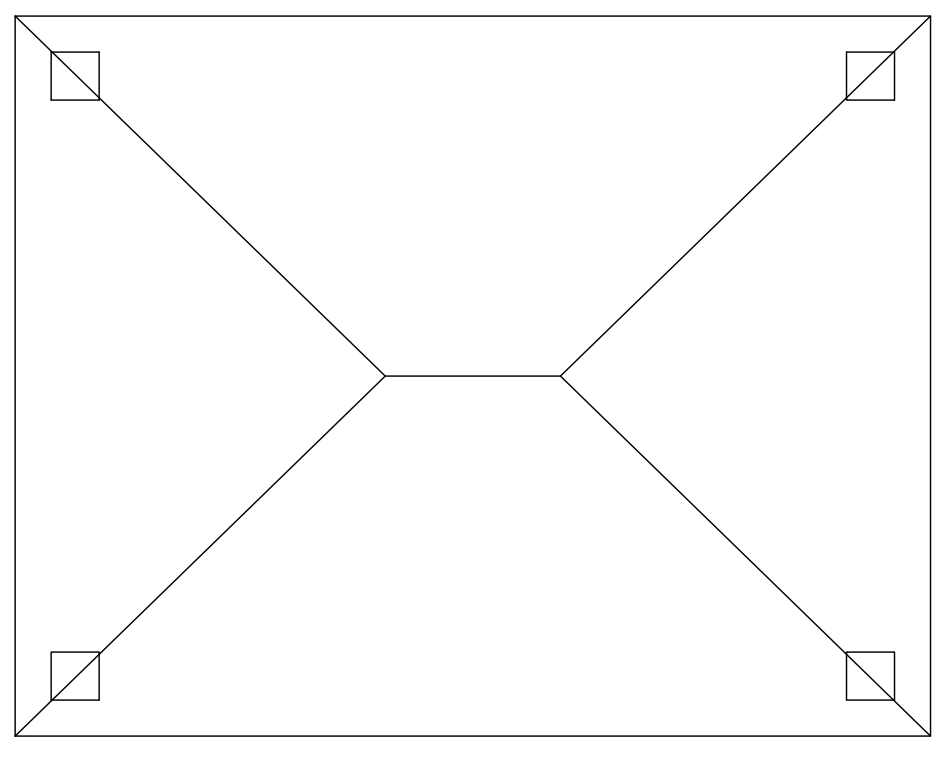

2 UPPER FLOOR REFLECTED CEILING PLAN
 AS03 SCALE 1/8" = 1'-0"

BID SET 1-5-10

Sheet no.
A503.2

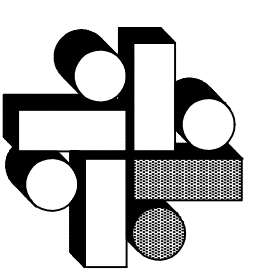

BIEBERLY ARCHITECTS
 227 north santa fe, suite 302
 post office box 1731
 salina, kansas 67402-1731
 phone: 785-823-9221
 fax: 785-823-9234
 dove@bieberlyarchitects.net

70 ROOM MOTEL
COMFORT INN & SUITES
 Parachute, Colorado
 OWNER: Jay Koshiya



drawing title:
REFLECTED CEILING UPPER FLOORS
 The design and details disclosed herein are the exclusive property of BIEBERLY ARCHITECTS, PA and shall not be modified, reproduced or used in whole or in part without prior written consent of BIEBERLY ARCHITECTS, PA.

date: 1-5-2010
 project no. 200216
 drawn by: DDB
 checked by:
 revisions: